


**HARYANA POLICE  
HOUSING CORPORATION,  
PANCHKULA**

**PROJECT :**  
Design for Garages for  
Police Lines

**Notes:**

SCHEDULE OF JOINERY			
S.NO.	SIZE	CALL	TOP
D1	3'-6"X7'-0"	—	7'-0"
D2	3'-0"X7'-0"	—	7'-0"
D3	2'-6"X7'-0"	—	7'-0"
W	8'-0"X8'-0"	2'-6"	8'-6"
W1	4'-0"X3'-6"	5'-0"	8'-6"
V	8'-0"X3'-6"	10'-0"	13'-6"
V1	6'-0"X3'-6"	10'-0"	13'-6"
V3	4'-0"X1'-6"	7'-0"	8'-6"

REVISION DATED 30/10/17  
ROOF PROJECTION HAS BEEN PROVIDED  
2'-3" WIDE.

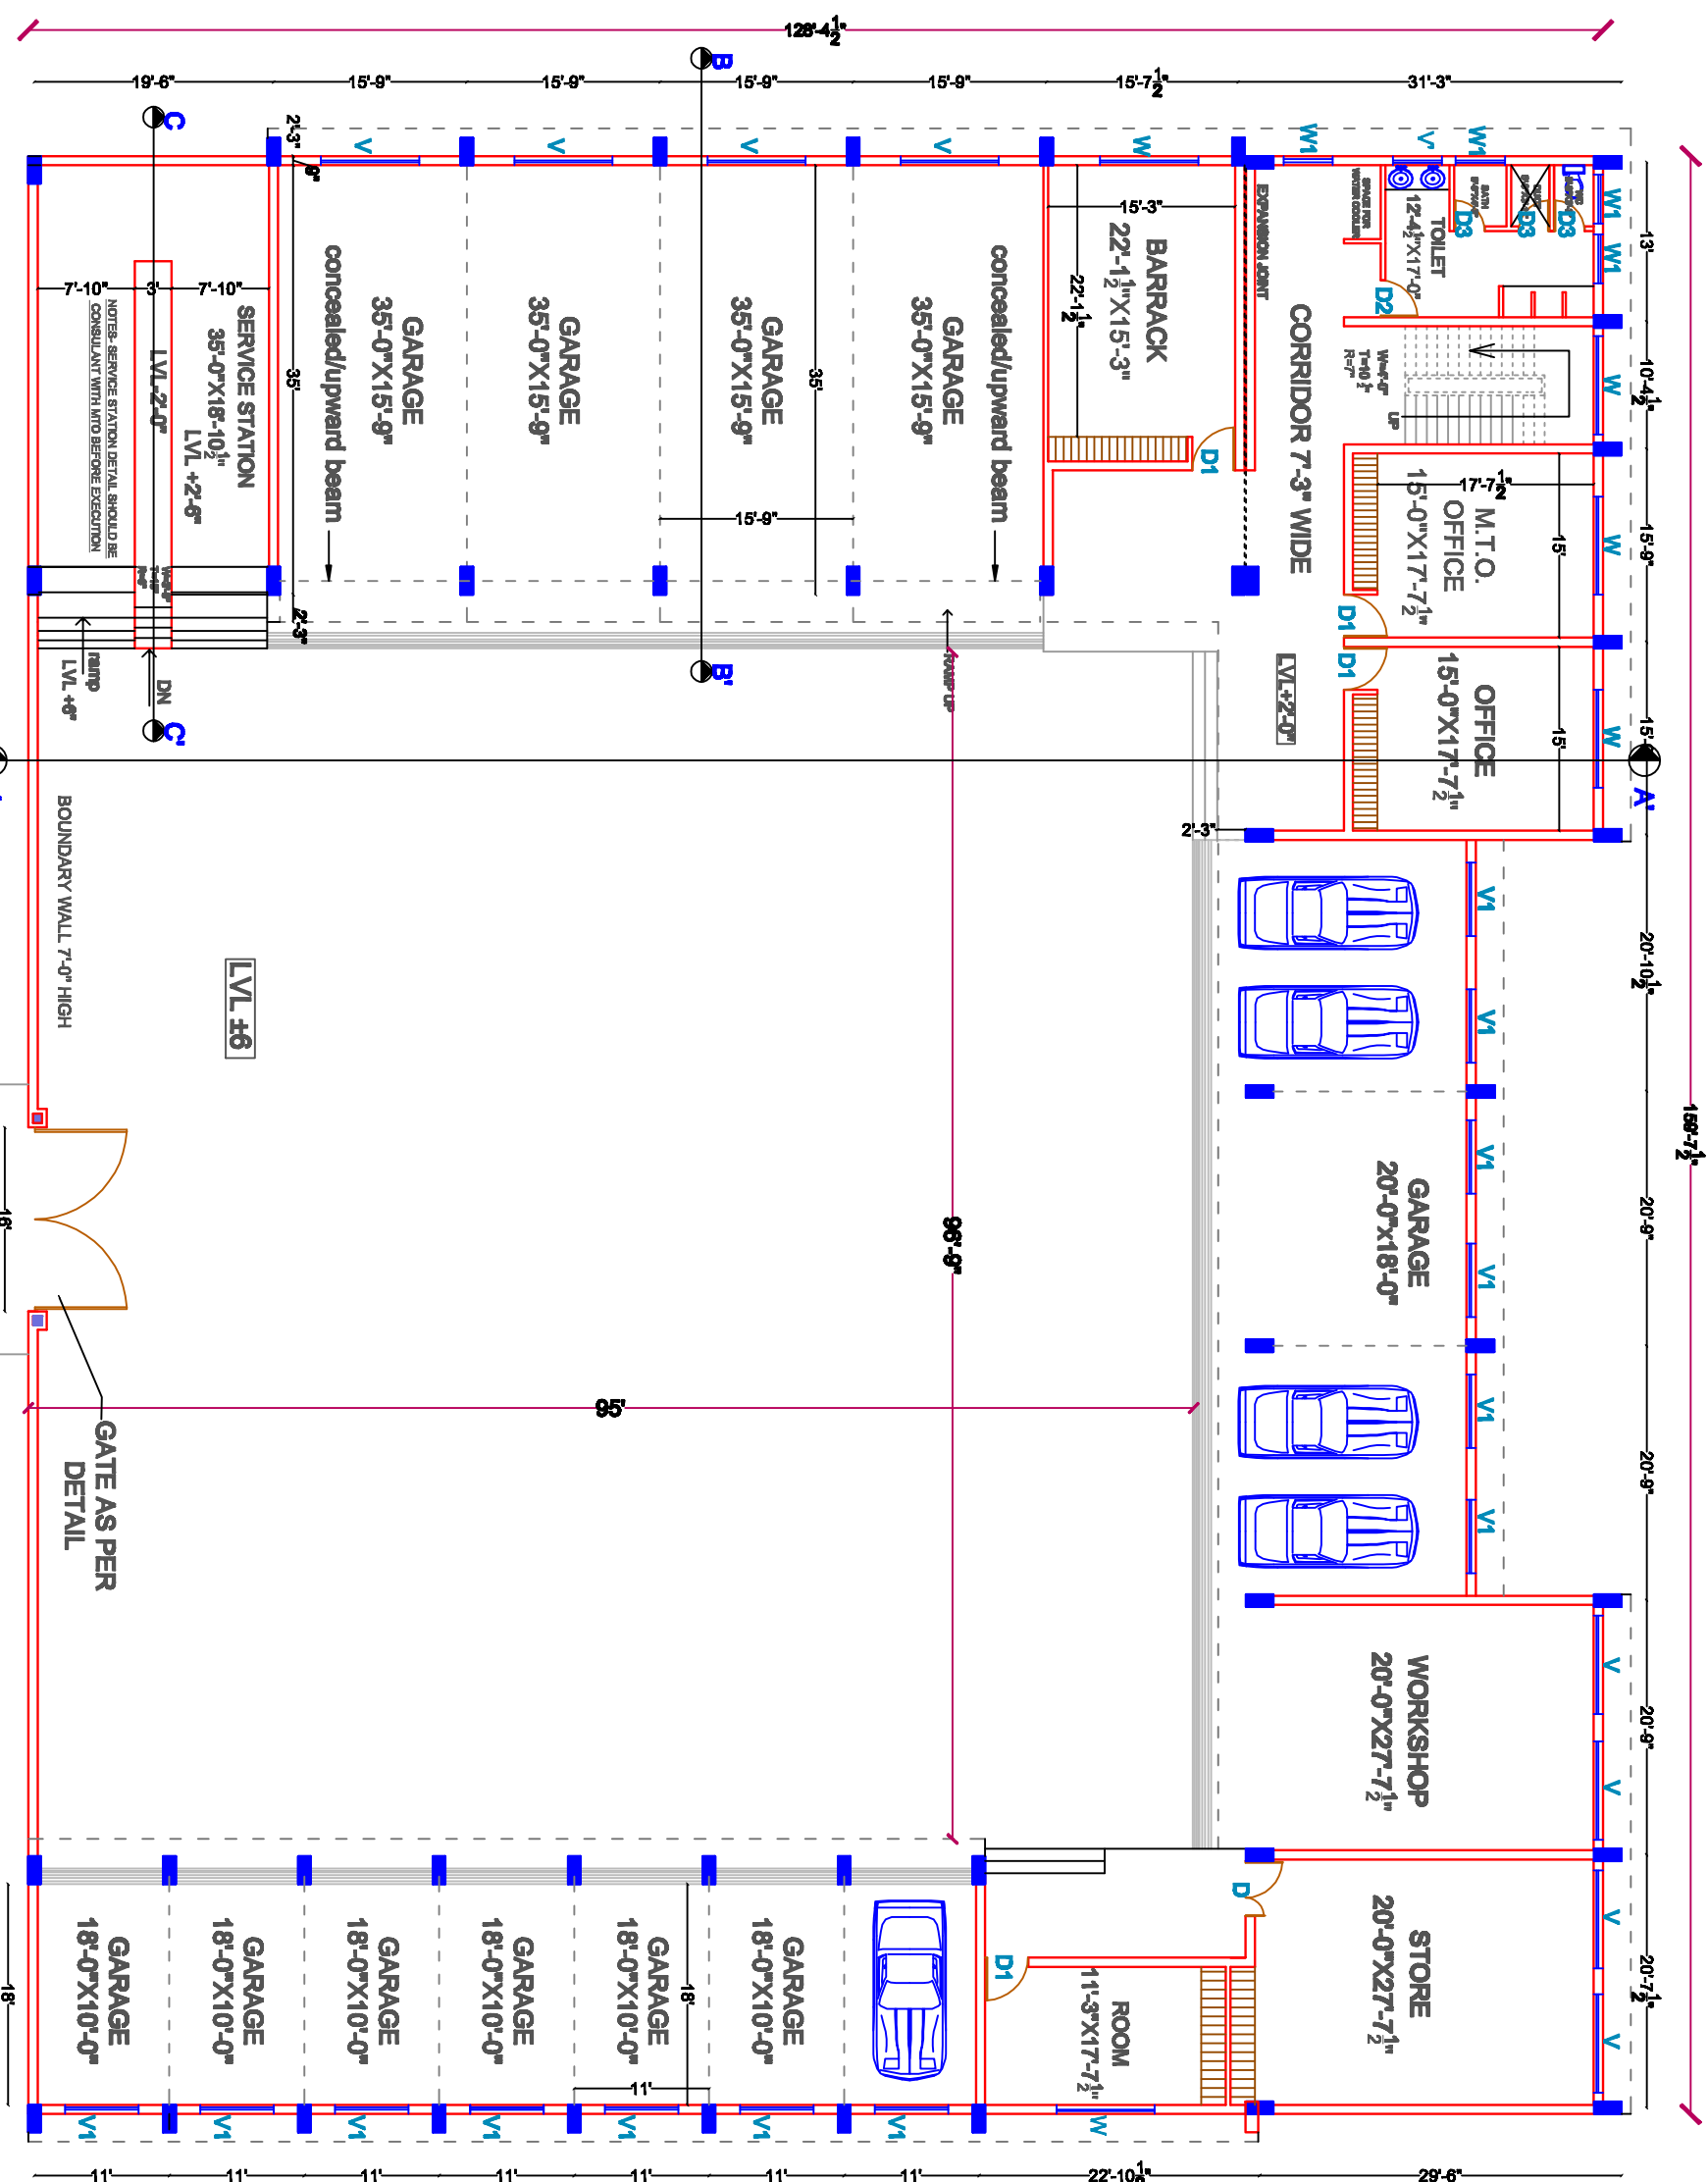

**GROUND FLOOR PLAN**

AREA-10017 sqft  
MUMTY- 235 sq.ft  
TOTAL-10252 sq.ft

M.D.:		CHIEF ARCHITECT:	
ARCHITECT:		SENIOR ARCHITECT:	
SCALE:		DATE:	
N.T.S		25.05.2018	
DEALT BY:		ORIENTATION/CHECKED BY:	
DWG NO.:		JOB NO.:	
01		1071	
TITLE: GROUND FLOOR PLAN			