


PRODUCED BY AN AUTODESK EDUCATIONAL PRODUCT

PRODUCED BY AN AUTODESK EDUCATIONAL PRODUCT

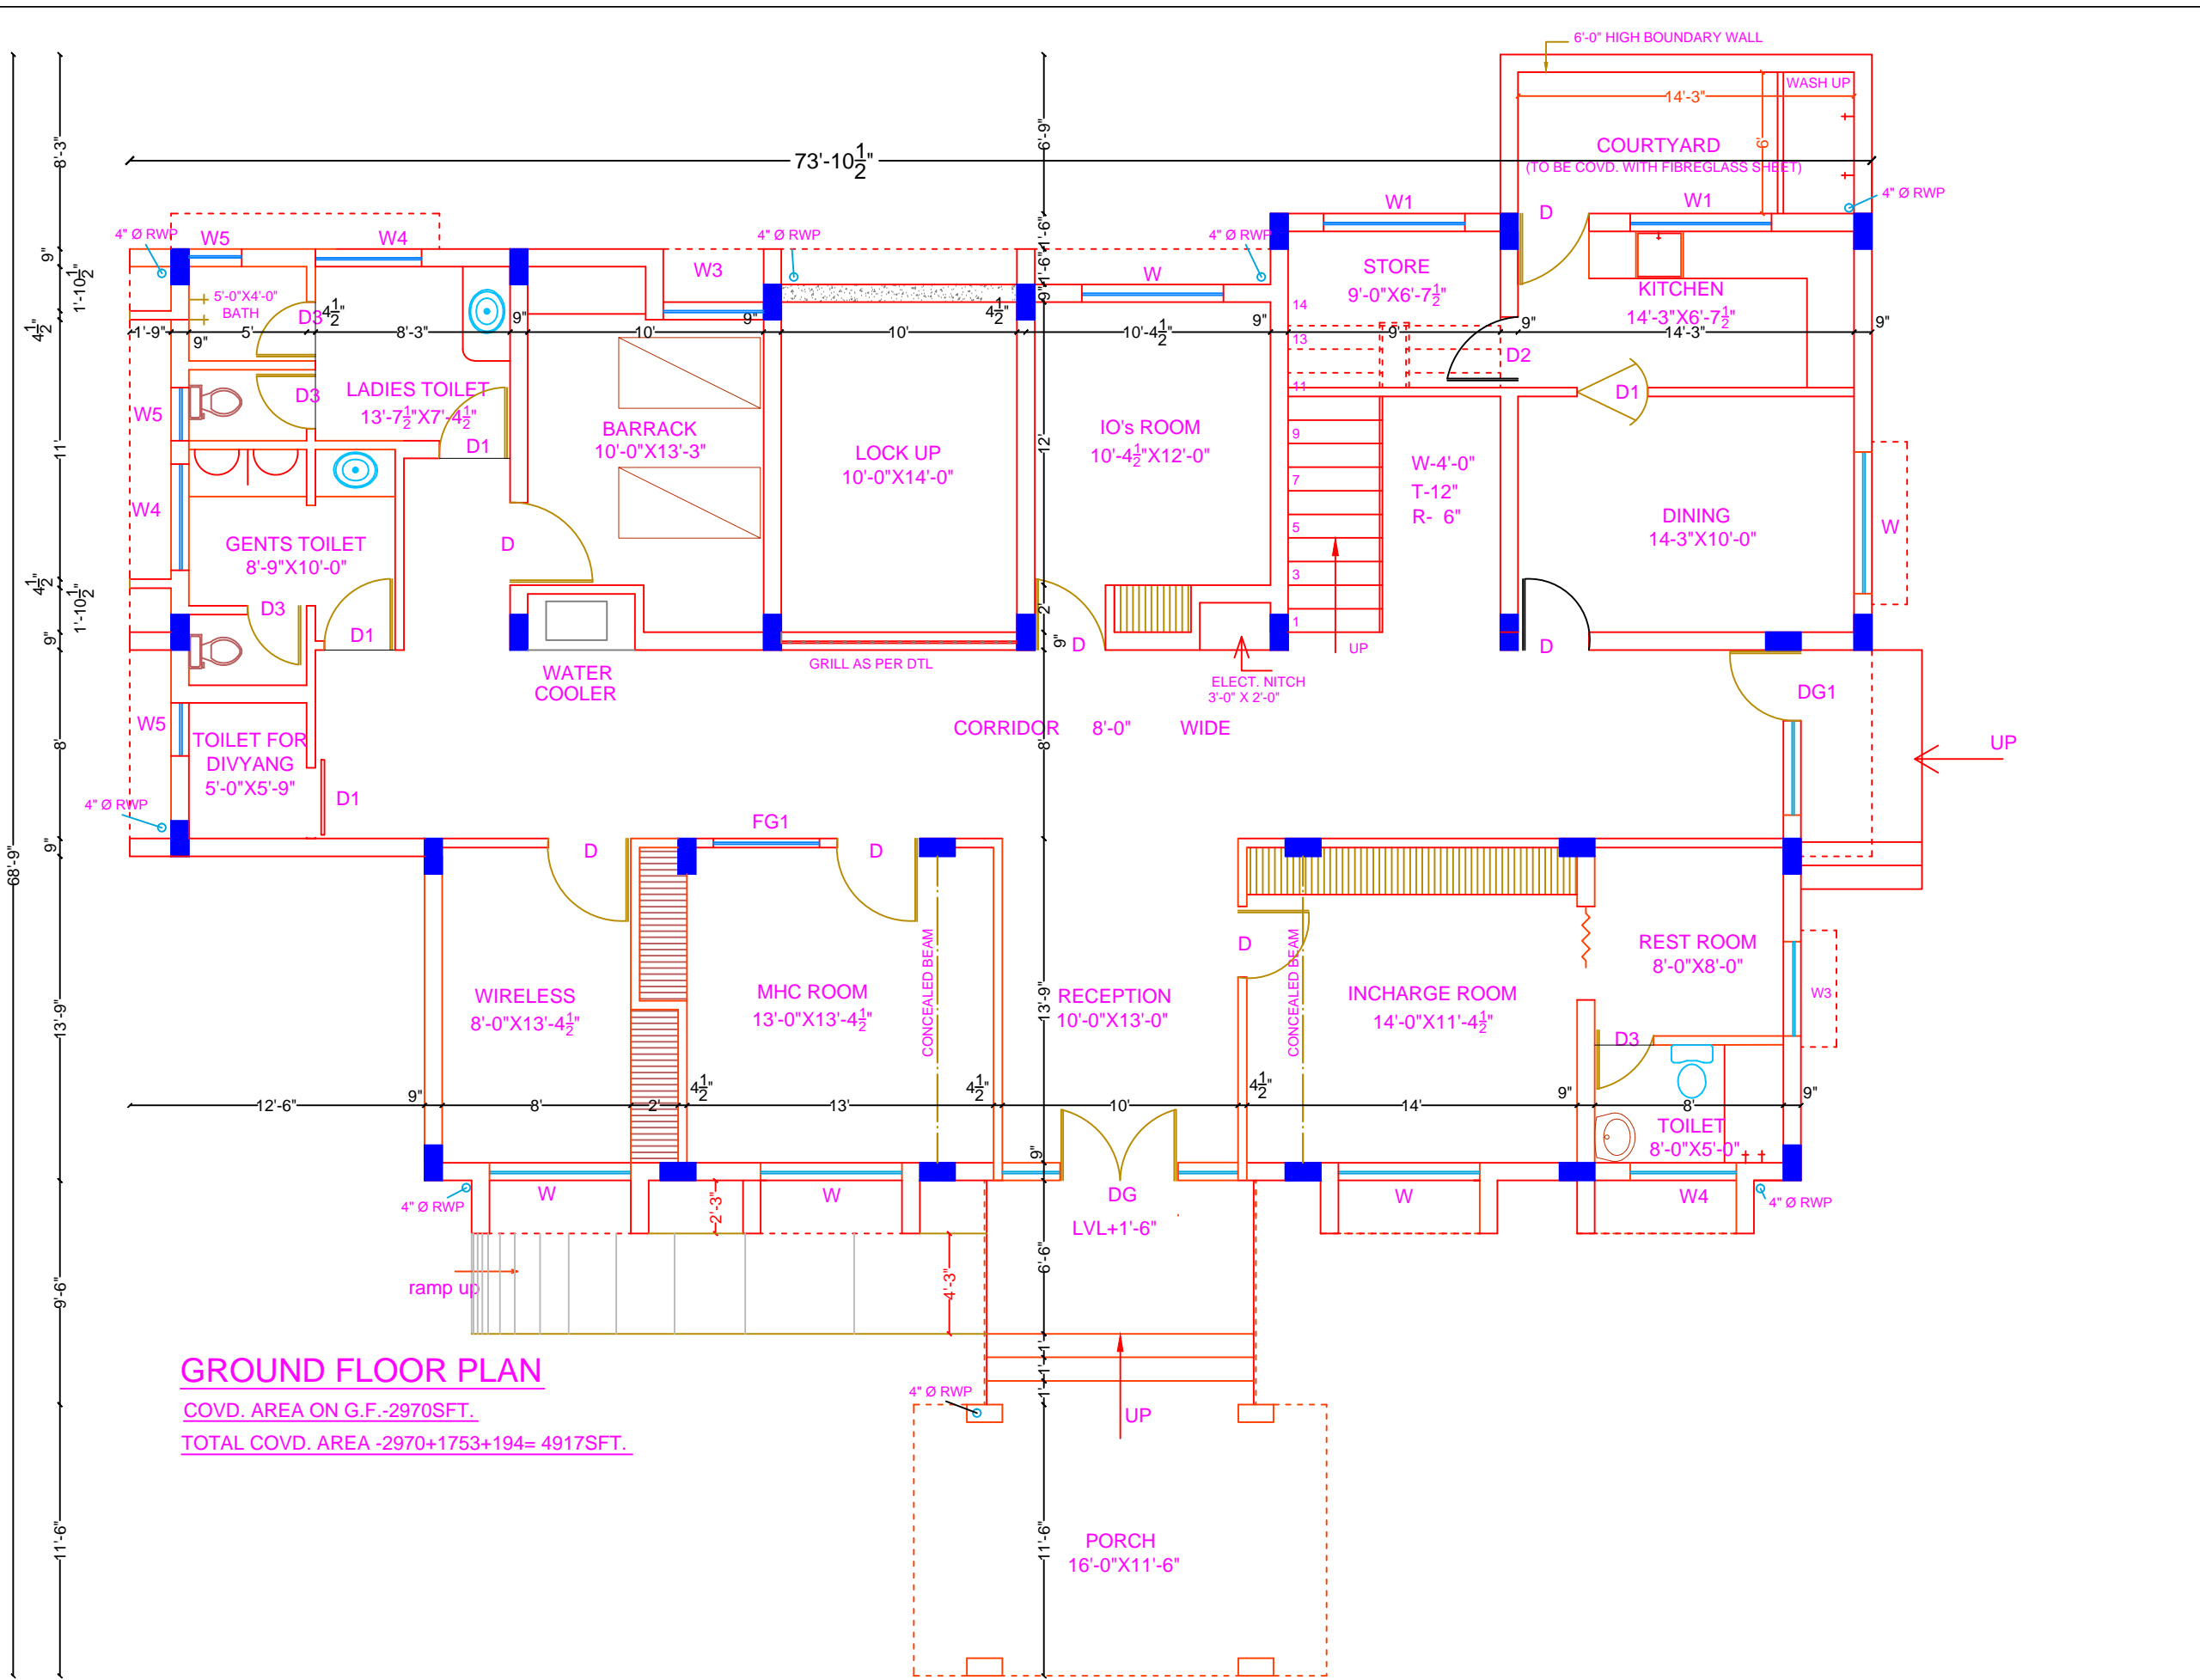

GROUND FLOOR PLAN

COVD. AREA ON G.F.-2970SFT.
 TOTAL COVD. AREA -2970+1753+194= 4917SFT.

HARYANA POLICE
 HOUSING CORPORATION
 PANCHKULA

STD. DESIGN FOR FOR
 POLICE POST

S.NO.	NAME	SIZE	CILL	TOP
1	DG	10'-0"X9'-0"	----	9'-0"
2	DG1	7'-0"X9'-0"	----	9'-0"
3	D	3'-6"X9'-0"	----	9'-0"
4	D1	3'-0"X7'-0"	----	7'-0"
5	D2	3'-6"X7'-0"	----	7'-0"
6	D3	2'-6"X7'-0"	----	7'-0"
7	W	6'-0"X6'-6"	2'-6"	9'-0"
8	W1	6'-0"X5'-6"	3'-6"	9'-0"
9	W2	4'-0"X6'-6"	2'-6"	9'-0"
10	W3	3'-0"X6'-6"	2'-6"	9'-0"
11	W4	4'-6"X4'-0"	5'-0"	9'-0"
12	W5	2'-3"X4'-0"	5'-0"	9'-0"
13	FG	6'-0"X3'-6"	3'-6"	7'-0"
14	FG1	4'-6"X5'-6"	3'-6"	9'-0"

NOTE:
 SIZE OF COLUMNS & BEAMS TO
 BE KEPT AS PER STRUCTURAL
 DESIGN.


REVISION:
 REVISION DATED 21-03-17 CB
 BEEN ADDED IN WIRELESS &
 INCHARGE ROOM. INTERNAL
 PLANNING OF GENTS TOILET IS
 ALSO AMENDED. SIZE OF STORE
 IS ALSO CHANGED ALONGWITH
 LOCATION OF WATER COOLER.

MD	
C.E.	C.A.
ARCH.	SR. ARCH.
DRG. NO. 1	SCALE:-
JOB NO.	DATE 20-03-17


GROUND FLOOR PLAN

HARYANA POLICE
HOUSING CORPORATION
PANCHKULA

DESIGN FOR
POLICE POST

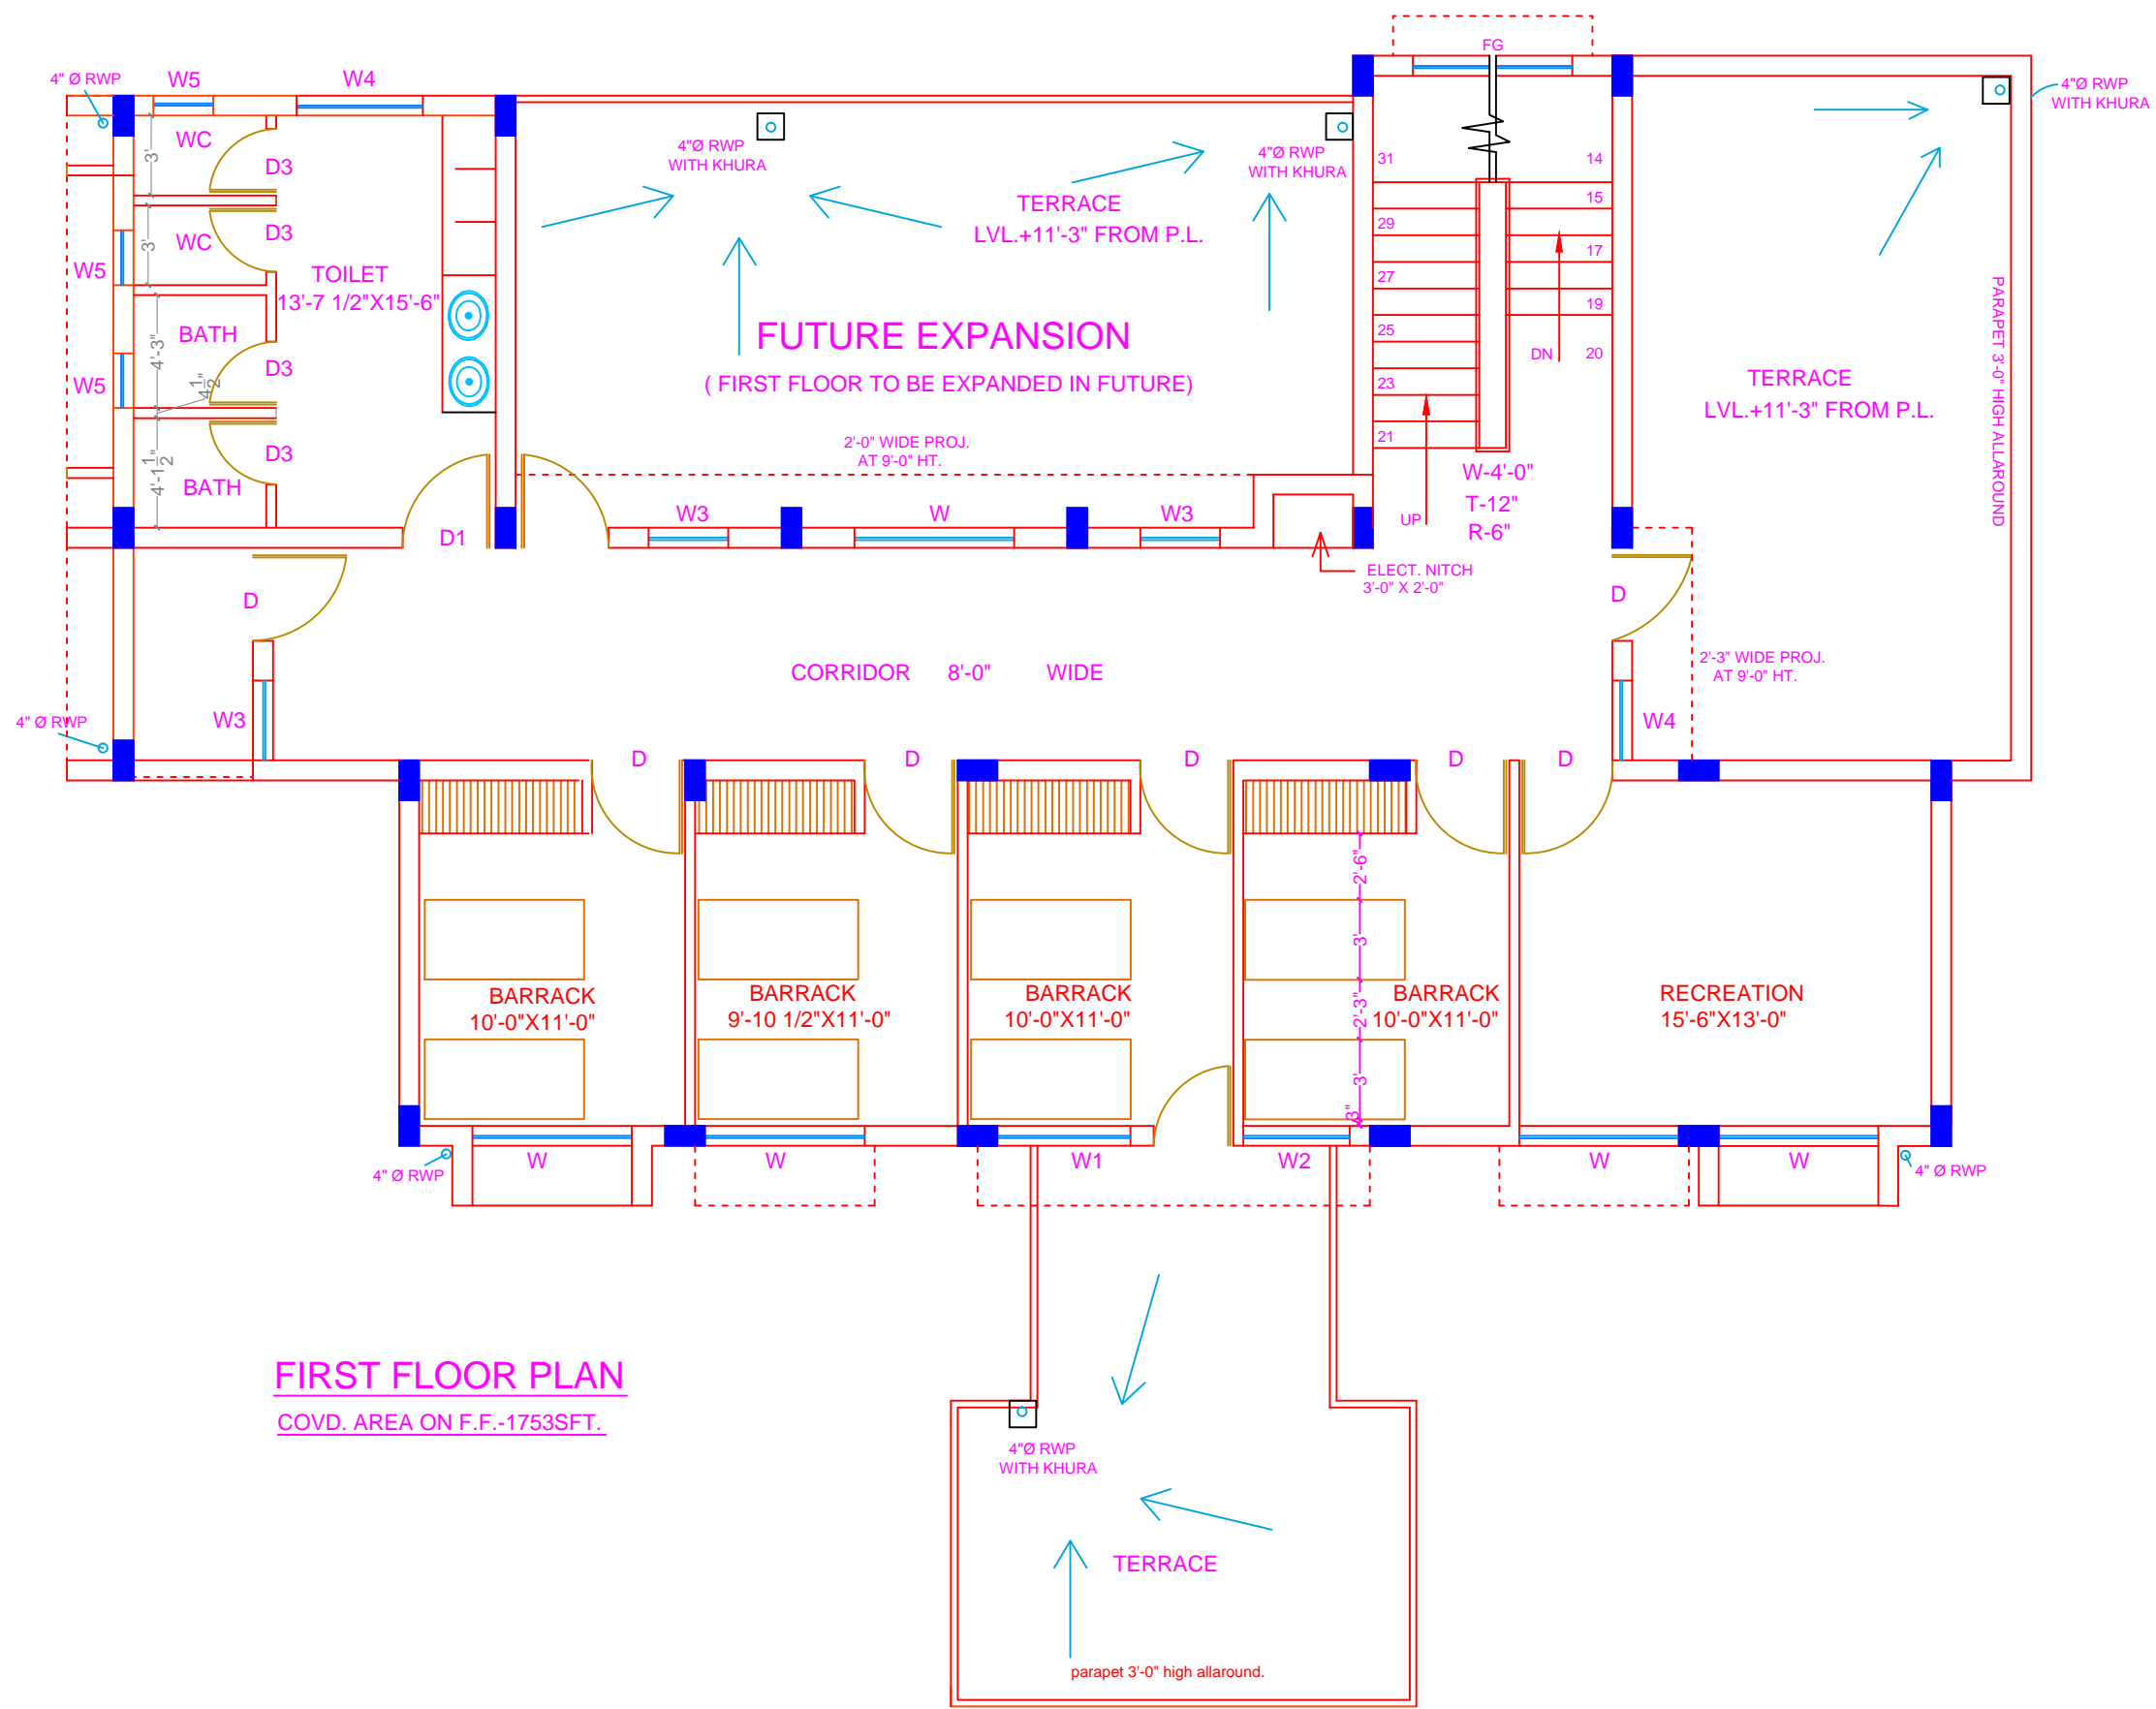

FIRST FLOOR PLAN
COVD. AREA ON F.F.-1753SFT.

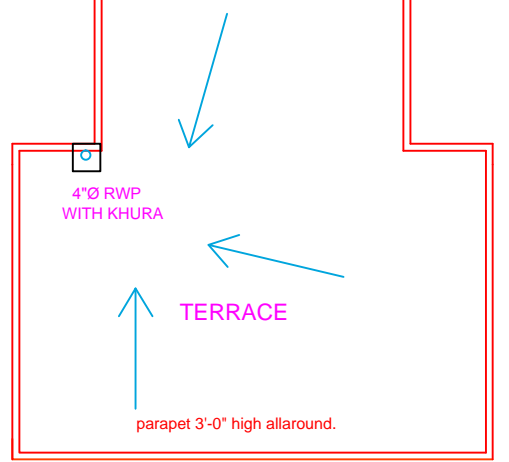

PRODUCED BY AN AUTODESK EDUCATIONAL PRODUCT

PRODUCED BY AN AUTODESK EDUCATIONAL PRODUCT

MD	
C.E.	C.A.
ARCH.	SR. ARCH.
DRG. NO. 2	SCALE:-
JOB NO.	DATE 20-03-17

FIRST FLOOR PLAN